


SEPTIC

LP TANK

~~SEPTIC~~

RECEIVED
TOWN OF CANANDAIGUA
DEVELOPMENT OFFICE
MAY 20 2016
FOR REVIEW

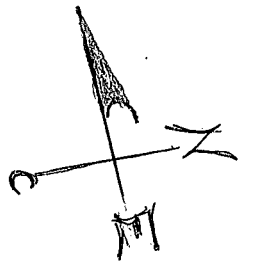

EDGE OF
ROADWAY

COUNTY RD 10

EXISTING -



MAN DOOR

ELECTRIC METER

45' 10"

70' 2"

3'

28'

28'


2700 COUNTY ROAD 10


TOWN OF CANANDAIGUA

SITE PLAN

3/8" SCALE

RECEIVED
 TOWN OF CANANDAIGUA
 DEVELOPMENT OFFICE
 MAY 20 2016
 FOR REVIEW

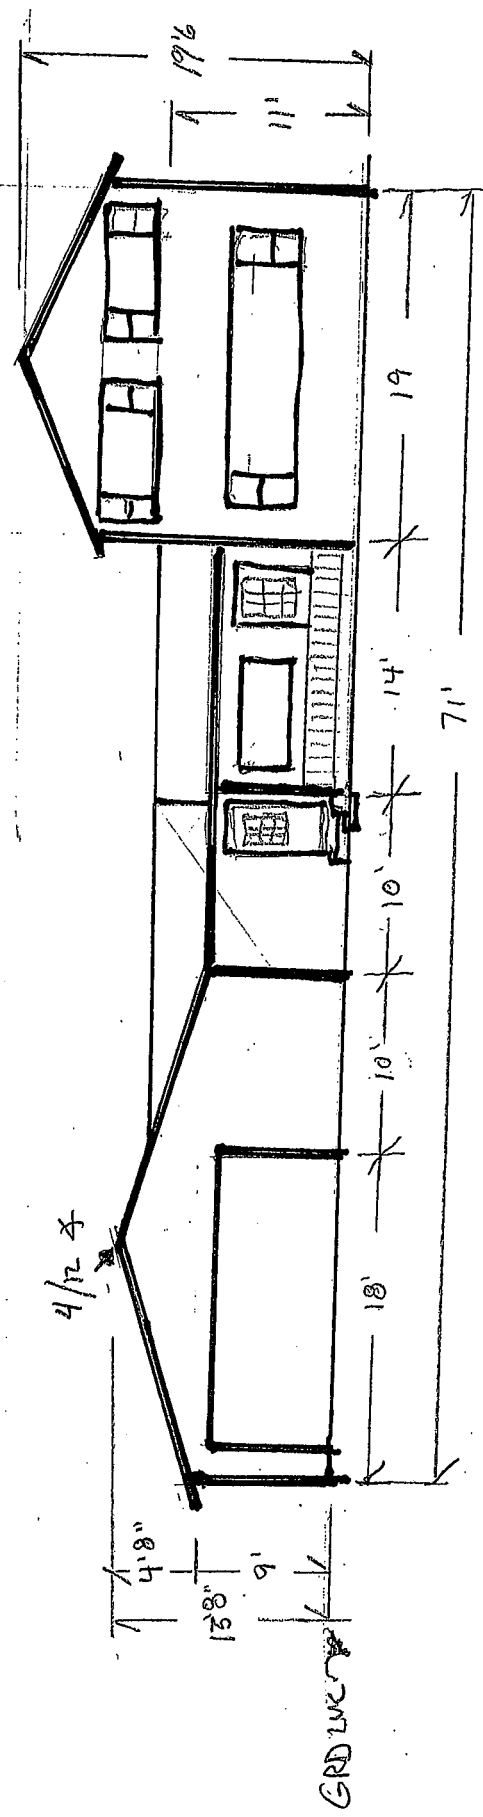

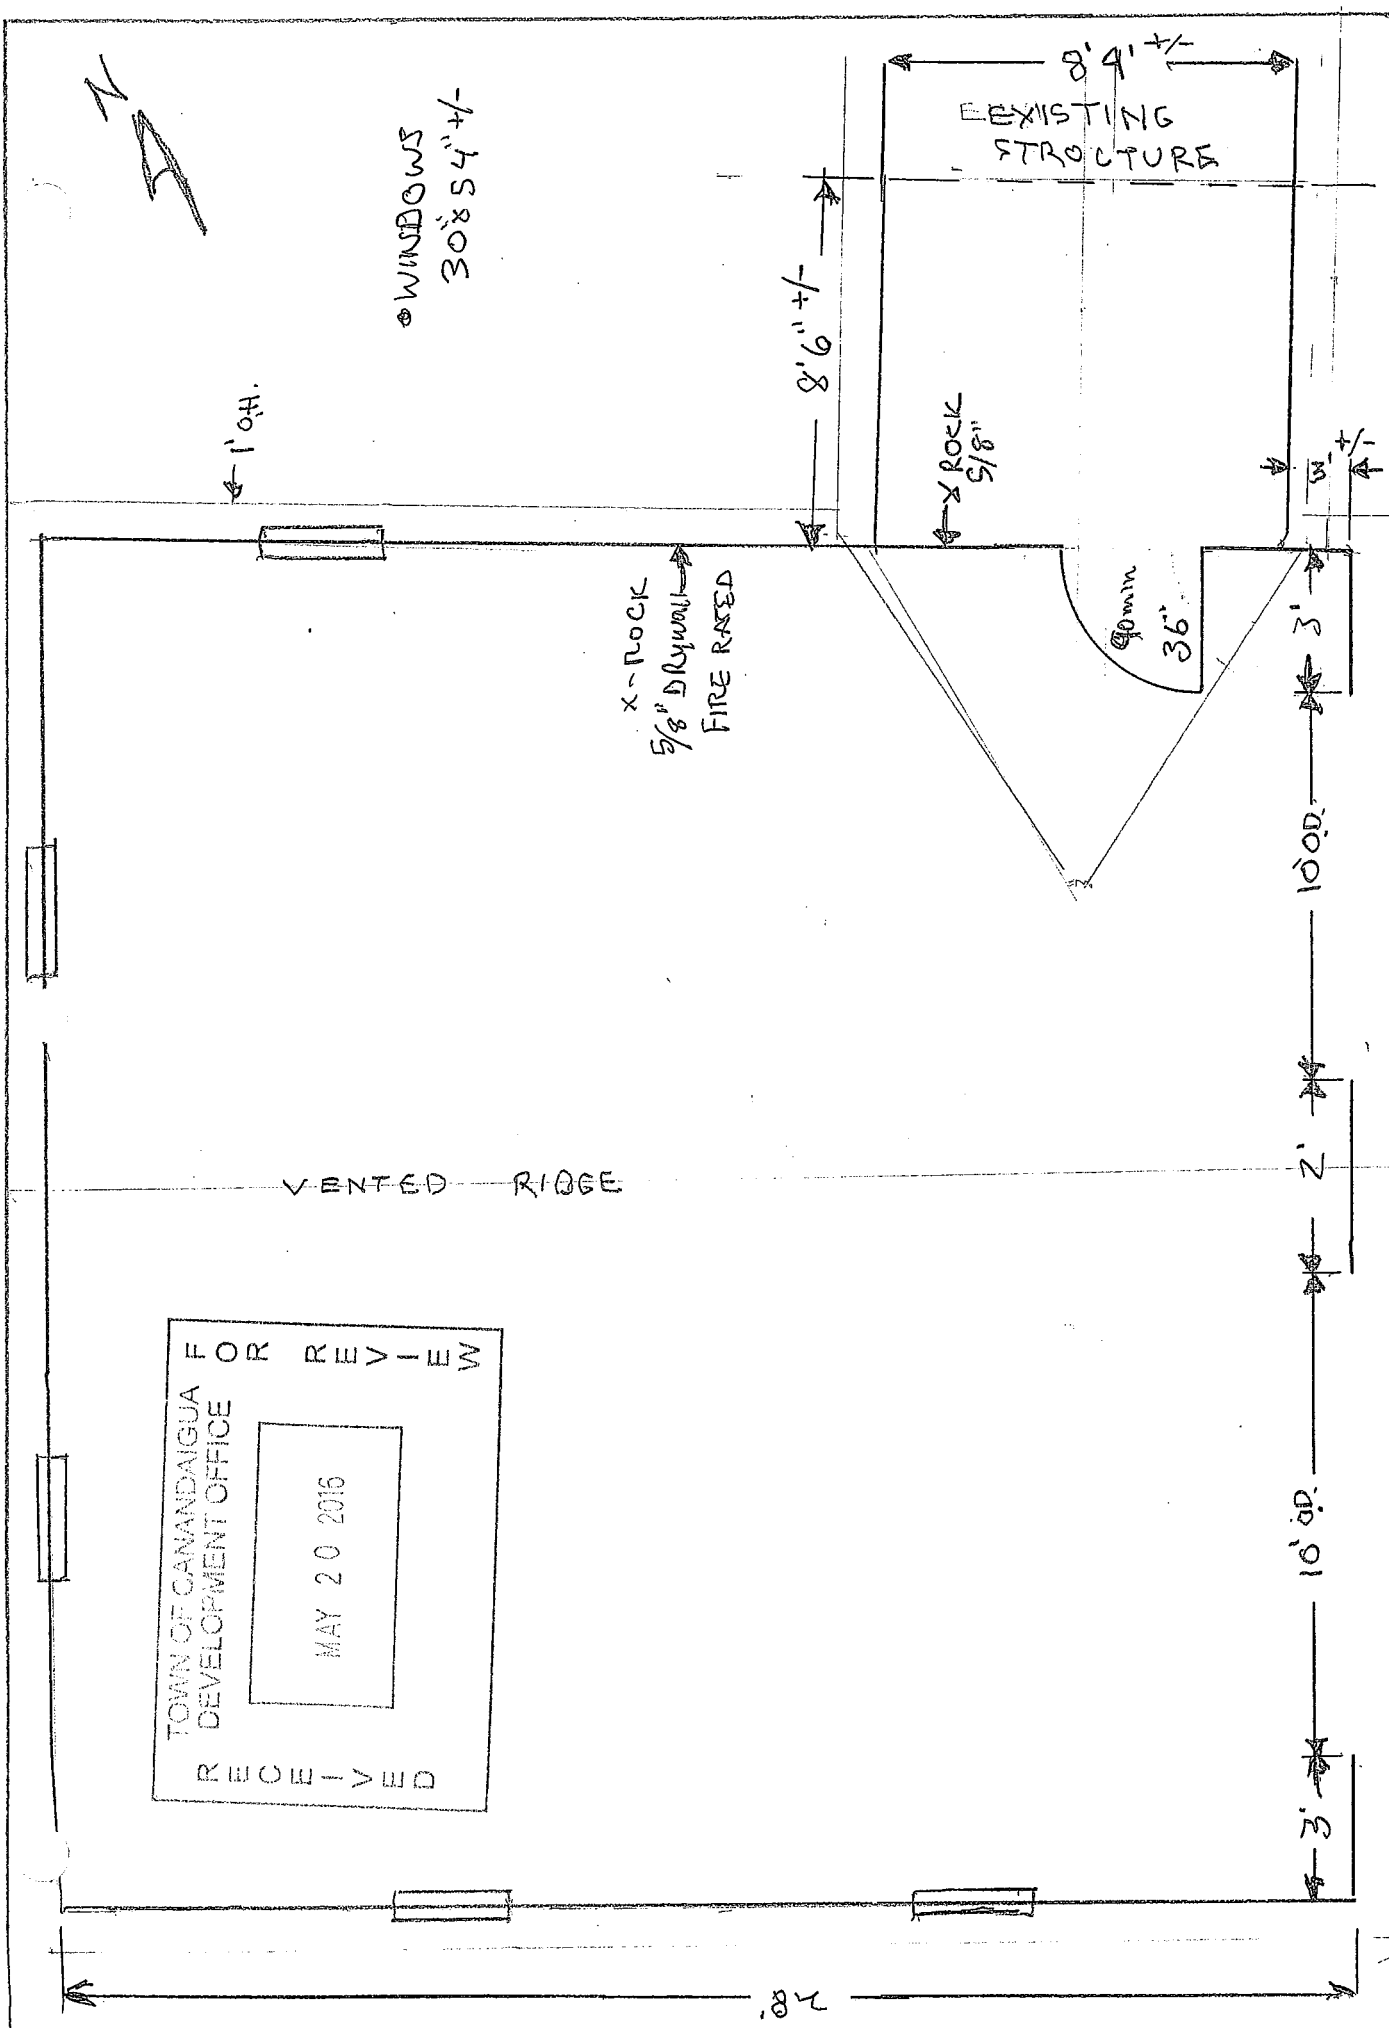

FOR REVIEW

TOWN OF CANANDAIGUA
DEVELOPMENT OFFICE

MAY 20 2016

RECEIVED



1700 CTY RD 10

FLOOR PLAN OF GARAGE

TOWN OF CANANDAIGUA

D. WEEKS

C. DAVIS

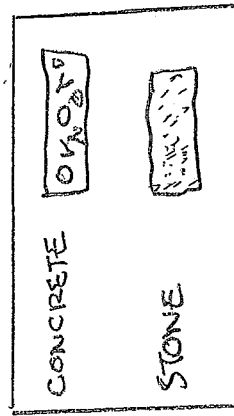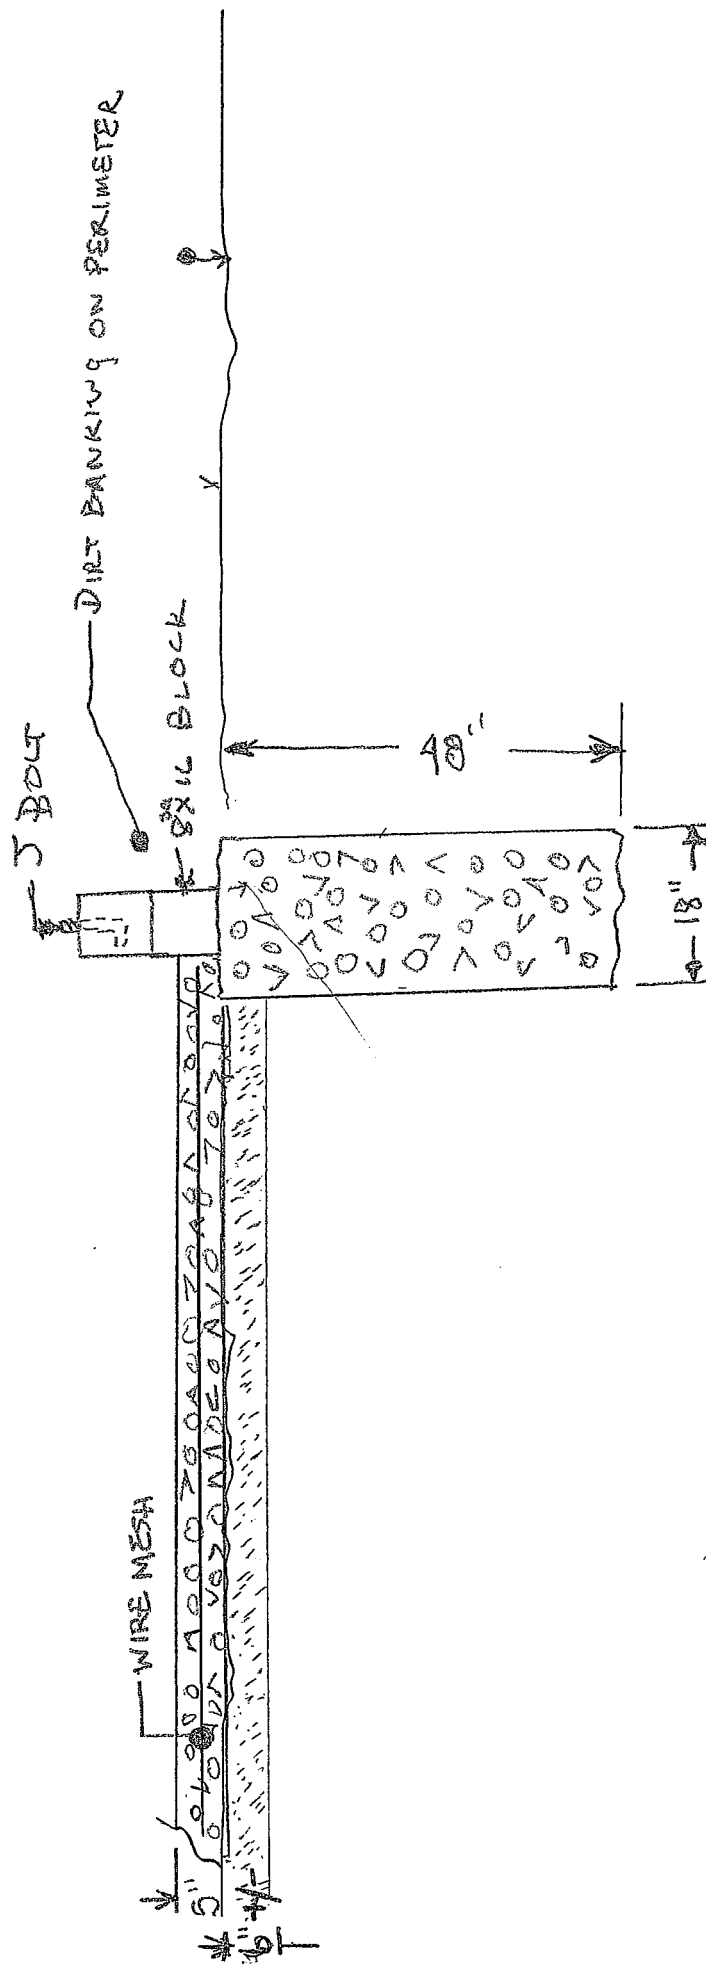

2700 CITY RD 10
1/2 MILE

FOOTER CROSS SECTION
TOWN CANNONDAIGUA

D. WEEKS
C. DAVIS

Job JOBS	Truss	Truss Type FINK	Qty 1	Ply 1	Job Reference (optional) <i>Ed Kristian</i>
FAULKNER TRUSS, HAMMONSPORT NY 14840, FRED TILLMAN			7.530 s Jul 14 2014 MiTek Industries, Inc. Wed Sep 09 13:05:09 2015 Page 1 ID:PS36badIuz5Wan8DwmFpQvyfNPo-EMrUit90BpNA1X4ZmlISp1WnjmeMRWV8x_VshmyfMyu		
1-0-0 1-0-0	7-6-8 7-6-8	14-0-0 6-5-8	20-5-8 6-5-8	28-0-0 7-6-8	29-0-0 1-0-0

Scale: 1/4"=1'

This drawing needs to be signed, dated and returned to Faulkner Truss Co. before an order is accepted.
Please fax to 315-536-8901 or e mail to faulknertrusscompany@yahoo.com
Thanks, Fred

