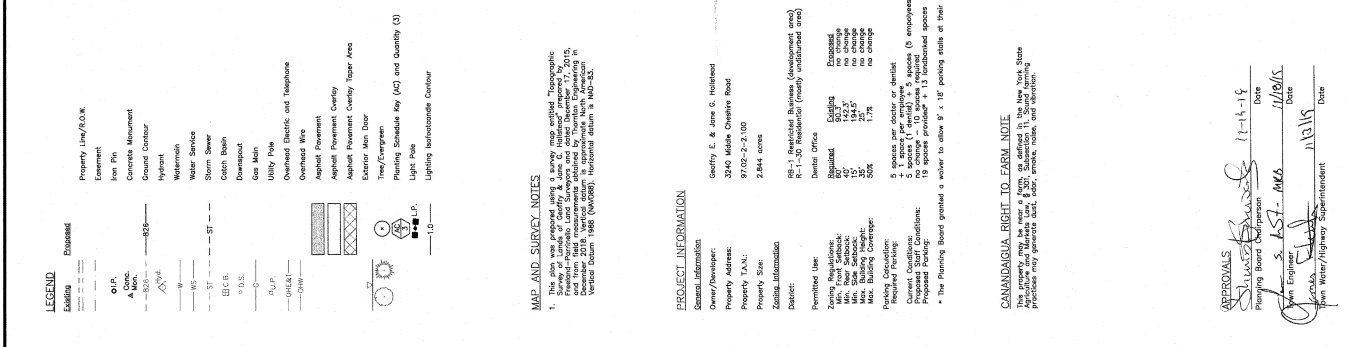


[illegible]


[illegible]

Step 1	Define the limits of disturbances, dewater and run garden locations, and existing trees field.
Step 2	Install self fence at the locations indicated on the plan.
Step 3	Install the new driveway into Middle Creative Road including stone base course material.
Step 4	Install stabilized construction entrance.
Step 5	Remove asphalt pavement areas to be abandoned.

- Litter and construction debris will be picked up on a daily basis and placed within covered trash receptacles.
- Construction materials that are temporarily stored on the work area will be secured with straps or chains, or covered to prevent wind transport.
- All points of entry into the storm drainage system will be screened to prevent entry of litter or debris.
- Construction chemicals and hazardous substances will be stored in approved containers and secured with padlocks.
- The contractor will remove appropriate spill containment devices on the jobsite off lines.

Contractor Name and Telephone	
Contractor Address	
Contractor Signature	Date

Planning Board Chairperson	Date
Shirley Schwartz	4-14-79
Town Engineer	Date
John S. Best, M.E.S.	11/18/79
Town Water/Highway Superintendent	Date
James F. Boud	11/7/79

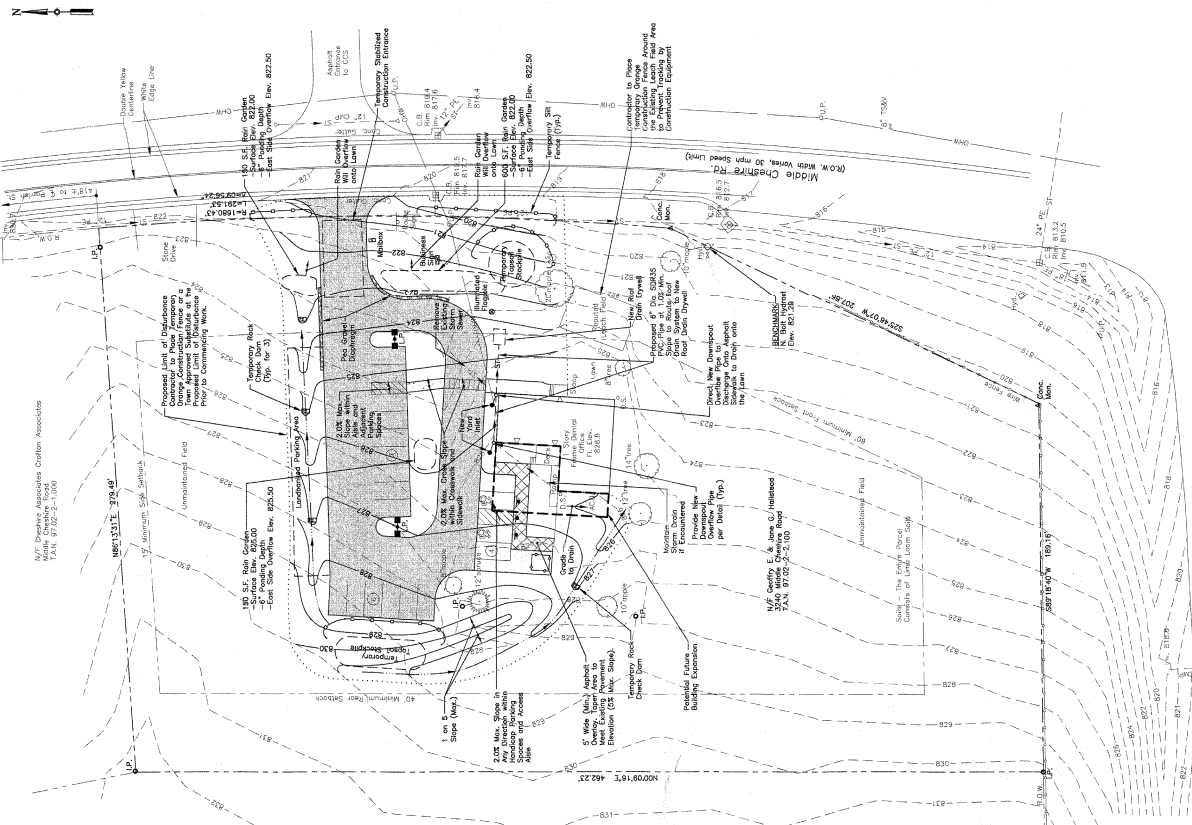

SCALE: 1" = 30'

FILE NAME: GRADING PLAN.DWG	DESIGNED BY: GFT
DRAWN BY: HKT	CHECKED BY: GFT
APPROVED BY: GFT	DATE: JUNE 2019
SCALE: 1" = 30'	PROJECT NO.: 18-710
SHEET NO.: 2 OF 5	DRAWING NO.: S-2

Grading, Drainage, and Soil Erosion/ Sediment Control Plan


Hallstead Dental
Office Parking Lot
Relocation

3240 Middle Cheshire Rd
Town of Canandaigua
Ontario County, NY



ALL RIGHTS RESERVED: No part of this document may be reproduced, stored in a retrieval system, or transmitted, in any form or by any means electronic, mechanical, photocopying, recording, or otherwise without the prior written authorization of Thomson Engineering U.P.

COP9592HT

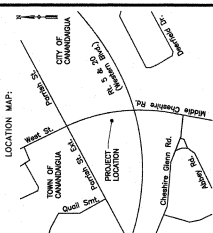

LANDSCAPING NOTES

1. All plants shall meet or exceed the requirements set forth in the latest edition of the American Standard for Nursery Stock by the American Association of Nurserymen.
2. Upon completion and acceptance of the landscaping by the Town of Canandaigua, a two (2) year maintenance guarantee is required.
3. All planting beds to receive 3" of shredded hardwood bark mulch and weed barrier.
4. All plants are to be planted within 20' of overhead area or within 5' of underground.
5. Stake out and wrap tree trunks upon planting.
6. Fertilizing liquid fertilizer to consist of 4 parts of liquid and 1 part solid mix. Provide 10 lbs. of 5-10-5 fertilizer per 1 cubic yard of planting material.
7. Irrigation system to be installed.
8. All plants to be planted within 20' of overhead area or within 5' of underground.
9. All plants to be planted within 20' of overhead area or within 5' of underground.
10. All plants to be planted within 20' of overhead area or within 5' of underground.
11. All plants to be planted within 20' of overhead area or within 5' of underground.
12. All plants to be planted within 20' of overhead area or within 5' of underground.
13. All plants to be planted within 20' of overhead area or within 5' of underground.
14. All plants to be planted within 20' of overhead area or within 5' of underground.
15. All plants to be planted within 20' of overhead area or within 5' of underground.

PLANTING SCHEDULE				
QUANTITY	KEY	SYMBOL NAME	COMMON NAME	NOTES
9	AC	Alnus incana	White Alder	8' to 10' Height
10	PS	Pinus strobus	Eastern White Pine	8' to 10' Height
3	SP	Sparganium angustifolium	Wetland Flag	24" Height
7	PD	Physocarpus opulifolius	Dwarf Firebush	18" to 24" Height
2	NJ	Nerium oleander	Common Oleander	8' to 10' Height
3	TD	Thuja 'Green Giant'	Green Giant Arborvitae	8' to 10' Height
2	AS	Asier canadensis	Flowering Dogwood	3' to 4' Height

CONSTRUCTION NOTES

1. The Contractor shall provide necessary utility to energize the new lighting system.
2. Chapter 200-27.

LIGHTING FIXTURE SCHEDULE		
Designation	No. of Fixtures	Lumens
A	Two Back to Back	8000
		Mounting Height on Pole



Site & Area

Item	Quantity	Unit	Price
1. 10' x 10' x 10' concrete pad	1	sq. ft.	10.00
2. 10' x 10' x 10' concrete pad	1	sq. ft.	10.00
3. 10' x 10' x 10' concrete pad	1	sq. ft.	10.00
4. 10' x 10' x 10' concrete pad	1	sq. ft.	10.00
5. 10' x 10' x 10' concrete pad	1	sq. ft.	10.00
6. 10' x 10' x 10' concrete pad	1	sq. ft.	10.00
7. 10' x 10' x 10' concrete pad	1	sq. ft.	10.00
8. 10' x 10' x 10' concrete pad	1	sq. ft.	10.00
9. 10' x 10' x 10' concrete pad	1	sq. ft.	10.00
10. 10' x 10' x 10' concrete pad	1	sq. ft.	10.00



APPROVALS

Planning Board Chairman: [Signature] Date: 11/15/15

Engineer: [Signature] Date: 11/15/15

Town Water/Highway Superintendent: [Signature] Date: 11/15/15

REVISIONS

NO.	DESCRIPTION	DATE	BY
1	PLANNING BOARD APPROVAL	11/15/15	GFT
2	TOWN ENGINEER REVIEW COMMENTS	11/15/15	GFT

THORNTON ENGINEERING LLP

20 Assembly Drive, Suite 100
Canandaigua, NY 14829
315.399.1100
thorntonengr.com

ALL RIGHTS RESERVED

THIS DOCUMENT IS THE PROPERTY OF THORNTON ENGINEERING LLP. IT IS TO BE USED ONLY FOR THE PROJECT AND SITE SPECIFICALLY IDENTIFIED HEREIN. ANY REUSE OR MODIFICATION OF THIS DOCUMENT WITHOUT THE WRITTEN PERMISSION OF THORNTON ENGINEERING LLP IS STRICTLY PROHIBITED.

LOCATION MAP

PROJECT NAME

Hallstead Dental Office Parking Lot Relocation

3240 Middle Cheshire Rd.
Town of Canandaigua
Ontario County, NY

DRAWING TITLE

Lighting and Landscaping Plan

FILE NAME: L1LANDSCAPE.DWG

DRAWN BY: HKI


CHECKED BY: GFT

DATE: JUNE 2019

SCALE: 1" = 30'

SHEET NO.: 18-710

DRAWING NO.: S-3

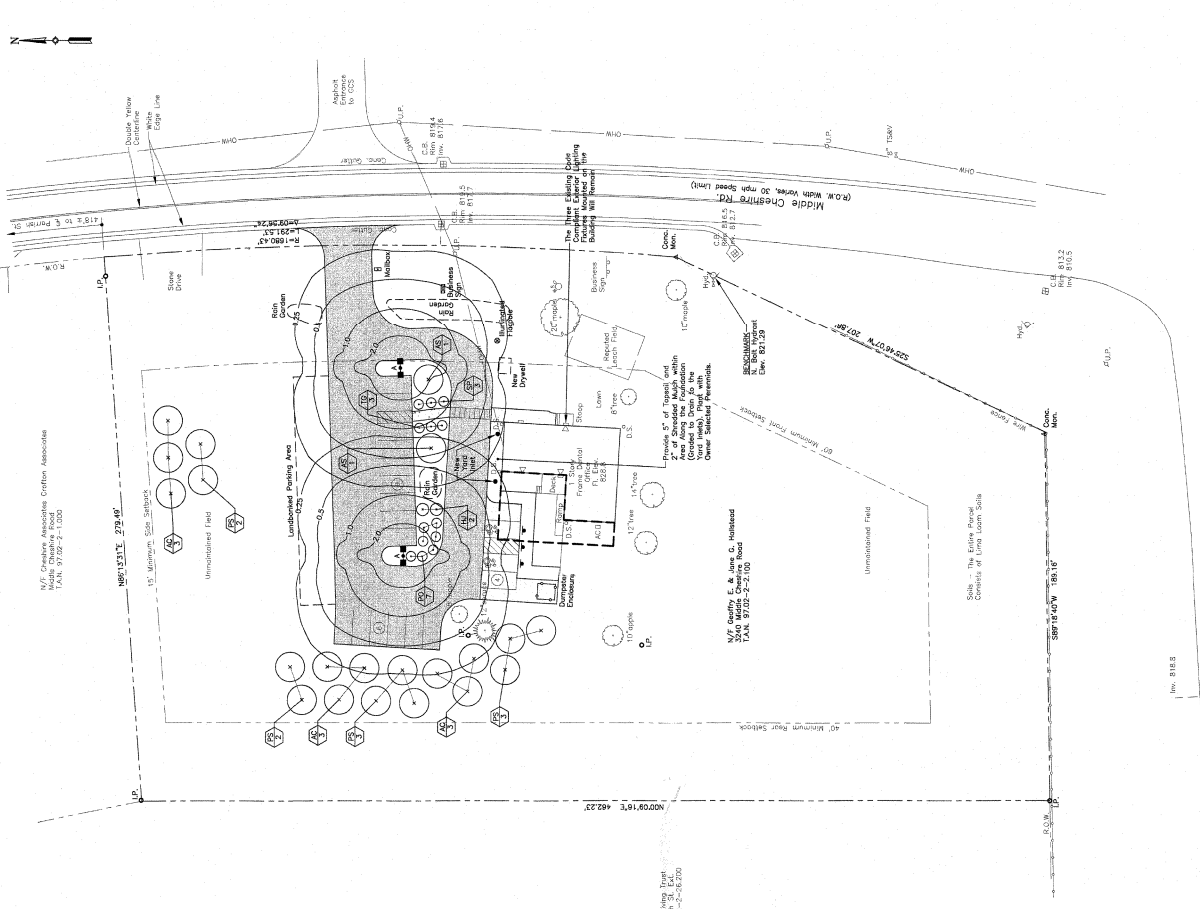

LIGHTING AND LANDSCAPING PLAN

SCALE: 1" = 30'

 
0 30 60

FEET

NTS RL 5 & US RL 20
(with 20' Buffer Zone)

It is a violation of New York State Education Law Article 145 Section 7209 for any person, unless he or she is acting under the direction of a licensed professional engineer or land surveyor, to offer an item in any way, if an item bearing the seal of an engineer or land surveyor is altered, the altering engineer or land surveyor shall affix to the item his or her seal and the notation "altered by" followed by his or her signature and the date of such alteration, and a specific description of the alteration.








CONSTITUTIONAL EDITORIALS

[illegible]

3240 Middle Cheshire Rd.
Town of Canandaigua
Ontario County, NY

Miscellaneous Details

--	--

 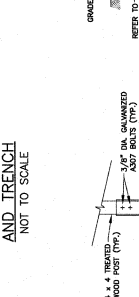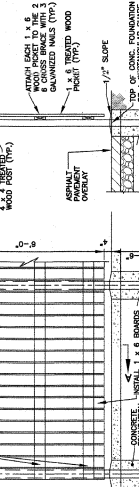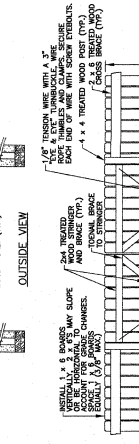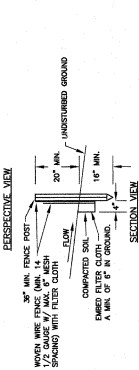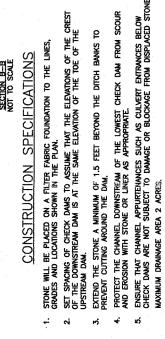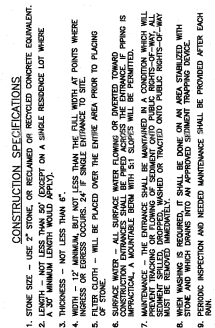

L
 C
 C
 N
 C
 T
 C
 W
 D

DUMPSITE ENCLOSURE
WOOD POST

NOT TO SCALE

100