

LUMINAIRE SCHEDULE

SYMBOL	QTY	LABEL	MOUNT HT.	ARRANGEMENT	LUMENS	LLF	LED COLOR	CATALOG NUMBER	DESCRIPTION
⬡	18	A	20	SINGLE	10,214	1	4000K	GS-LED-L30	LUMINA SERIES, SOLAR POWERED LED LIGHT FIXTURE BY GREENSHINE, TYPE 5 DISTRIBUTION


LIGHTING NOTES:

1. LIGHTING TO BE PROVIDED AS DETAILED IN LIGHTING SCHEDULE OR AN APPROVED EQUIVALENT.
2. ALL LIGHT FIXTURES TO BE DARK SKY COMPLIANT W/ FULL CUT OFF TO PROHIBIT LIGHT SPILL TO ADJOINING PROPERTIES.
3. ALL ELECTRICAL CONNECTIONS AND LAYOUT OF CONDUIT AND PULL BOX LOCATIONS TO BE COORDINATED WITH THE LIGHTING CONTRACTOR AND APPROVED BY THE OWNERS REPRESENTATIVE PRIOR TO FINAL INSTALLATION.
4. CONTRACTOR TO PROVIDE MANUFACTURERS CUT SHEETS TO OWNERS REPRESENTATIVE FOR ALL FIXTURES PRIOR TO FINAL INSTALLATION.


SEE MARKS ENGINEERING DWG. C-504
FOR LIGHTING DETAILS

PHOTOMETRIC PLOT

NTS

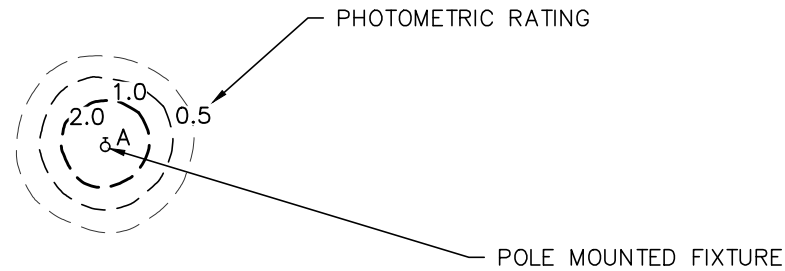

PRELIMINARY
NOT FOR CONSTRUCTION

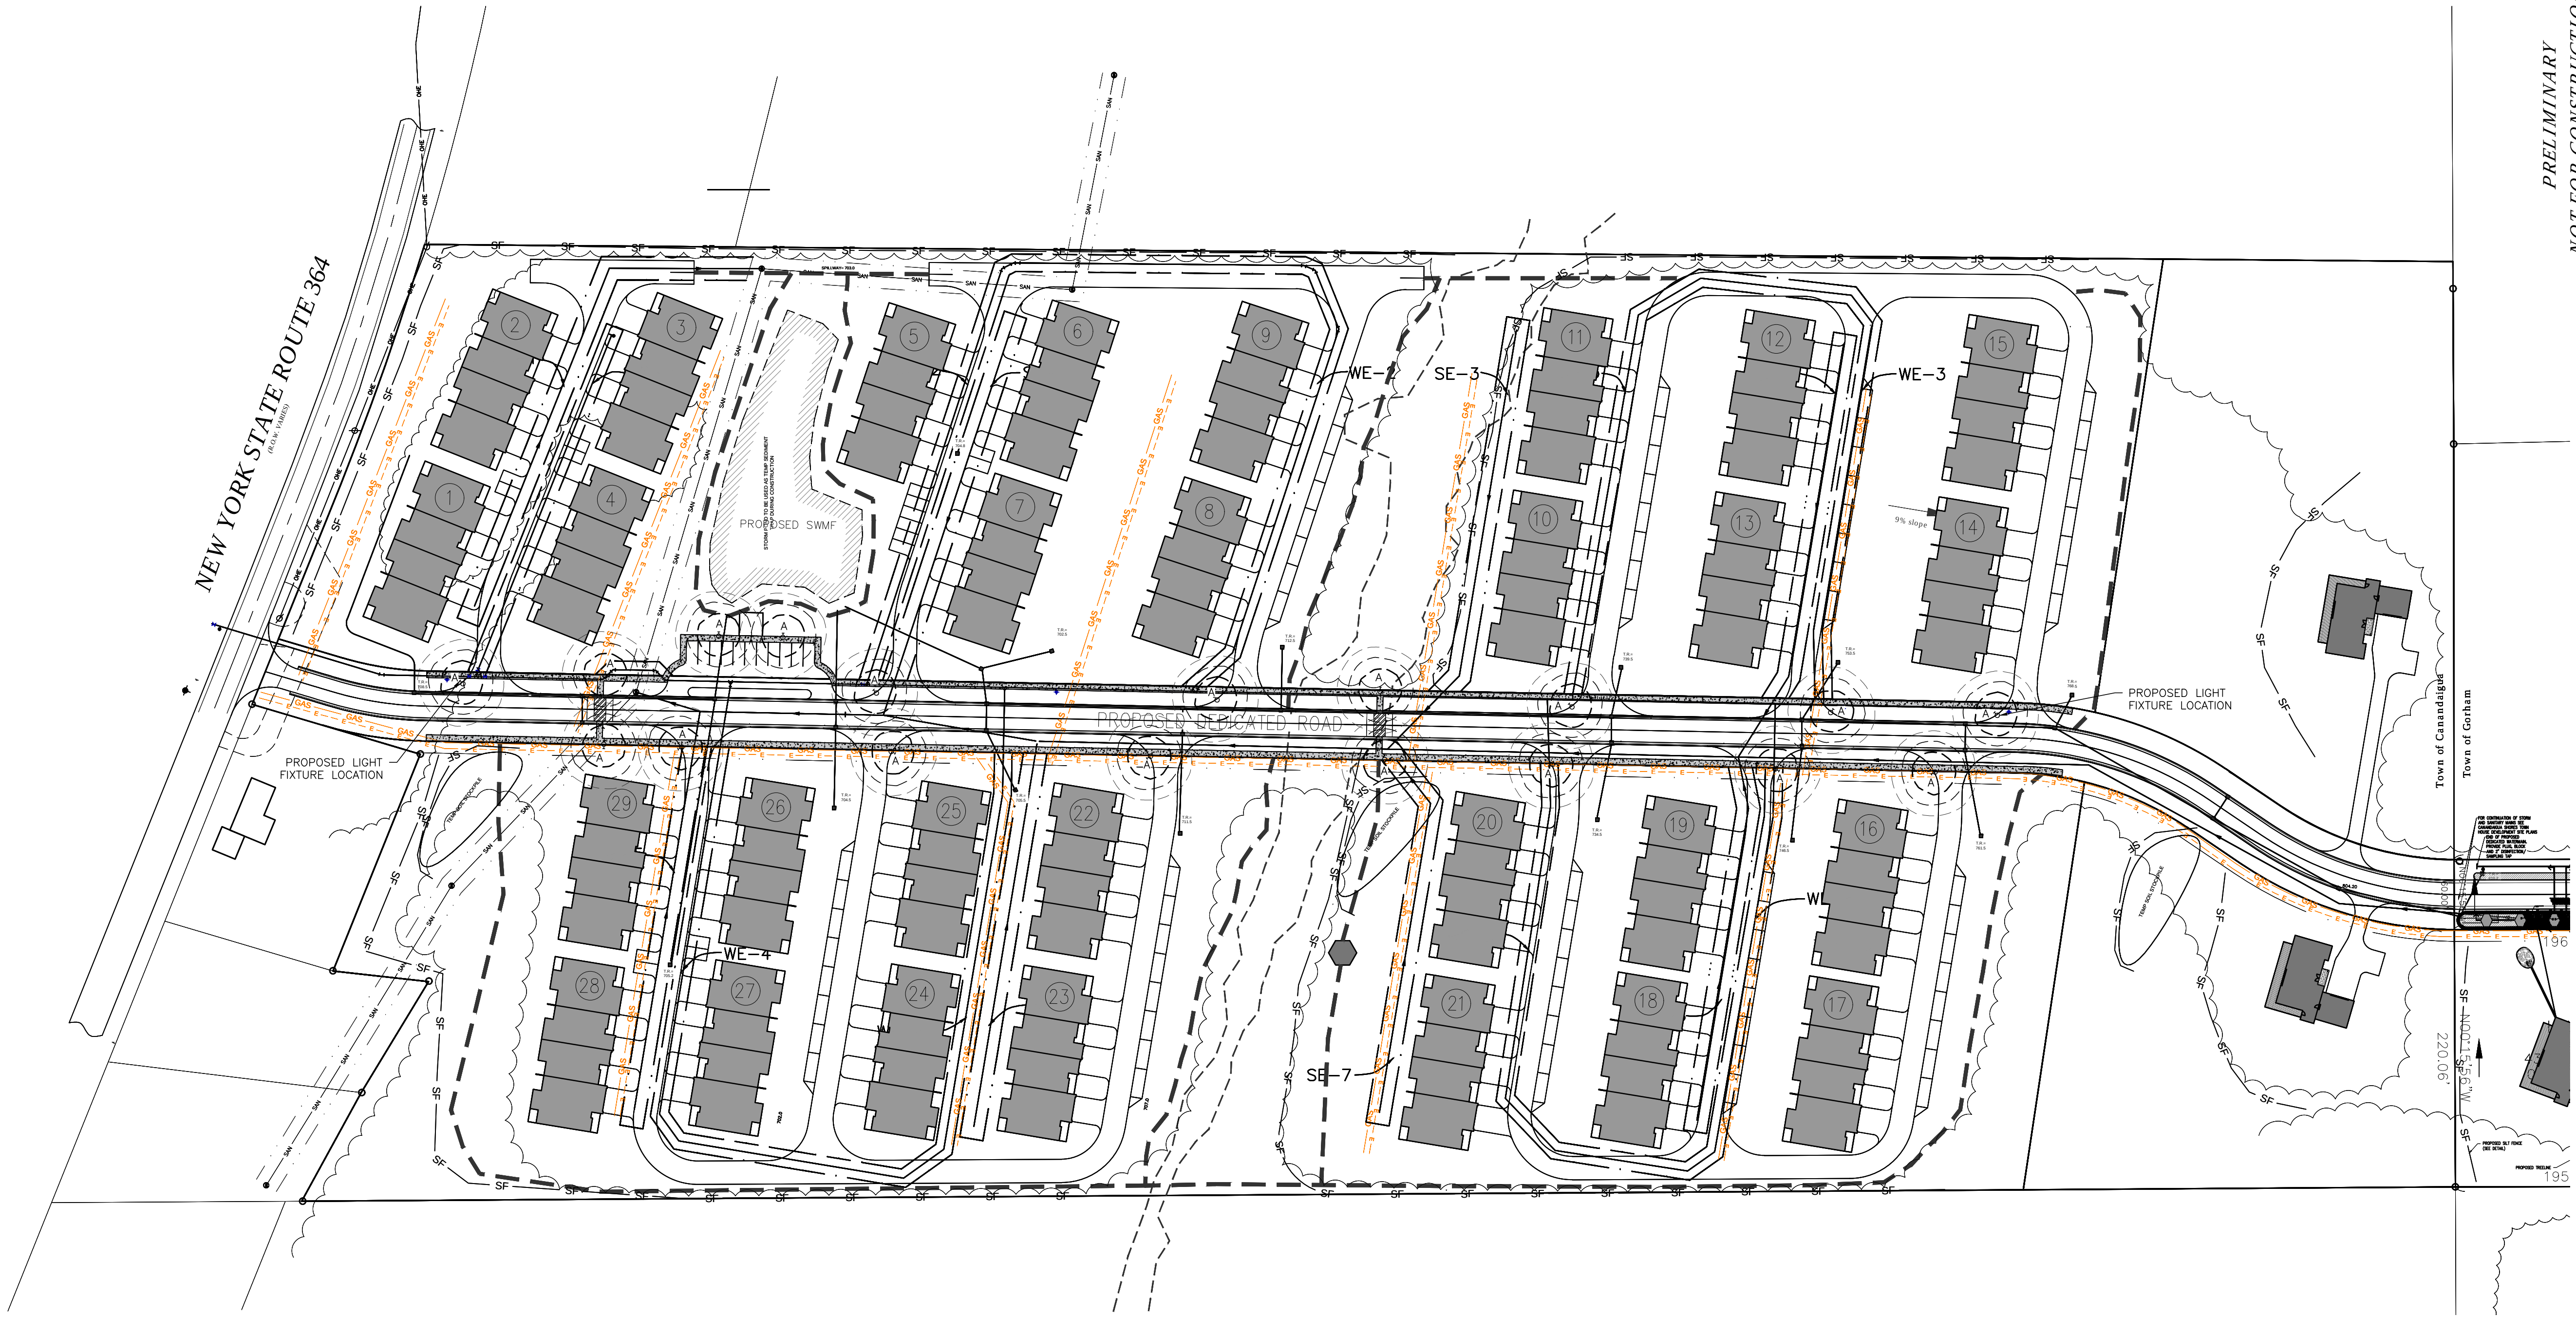

LEGEND

○ Iron pin or pipe found

● Benchmark

○ Utility pole

● Hydrant

● Light pole

PERC
TEST

● DEEP HOLE

EXISTING

----- elec -----

----- E/T -----

----- 99 -----

PROPOSED

----- E/T -----

----- 99 -----

Utility Lines

R.O.W. line

Property line

Easement line

Centerline

Drainage

Fence Line

Contour Line

ABBREVIATIONS:

EX-EXISTING

CPP-CORRUGATED POLYETHYLENE PIPE

O.C.-ON CENTER

SICPP-SMOOTH INTERIOR CORRUGATED POLYETHYLENE PIPE

UC-UNDERGROUND

CONC-CONCRETE

CO --CLEAN OUT

TYP-TYPICAL

R-RADIUS

BC-BOTTOM OF CURB

TC-TOP OF CURB

TW-TOP OF WALL

BW-BOTTOM OF WALL

BS-BOTTOM OF STAIRS

PERF-PERFORATED

MIN-MINIMUM

MAX-MAXIMUM

INV-INVERT

CB-CATCH BASIN

MH-MANHOLE

DI-DRAINAGE INLET



1 OVERALL PHOTOMETRICS PLAN
1"=80'

WATER/HIGHWAY SUPERINTENDENT DATE

PLANNING BOARD CHAIRMAN DATE

TOWN ENGINEER DATE

MarksEngineering

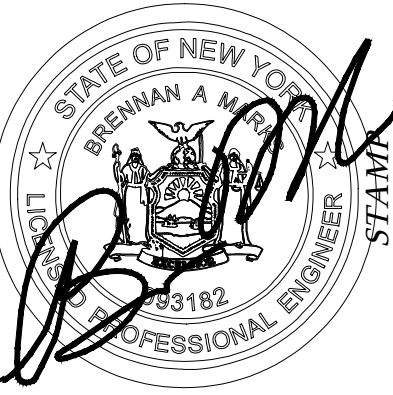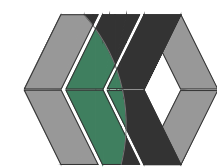

STAMP

REVISIONS

NO.	DATE	DESCRIPTION OF REVISION	BY
1	4/19/21	PER TOWN PRC MEETING	BAM
2	10/01/21	PER TOWN PLANNING BOARD REVIEW	BAM

SITE DEVELOPMENT PLANS PREPARED FOR:

CANANDAIGUA SHORES
TOWNHOME / RESIDENTIAL DEVELOPMENT
SHOWING LAND IN:
3535 STATE ROUTE 364 /0000 COUNTY ROAD 18
TOWN OF CANANDAIGUA / HOPEWELL

COUNTY OF ONTARIO STATE OF NEW YORK

DRAWING TITLE:
LIGHTING PLAN

DRAWN BY:	LGR
DESIGNED BY:	LGR
CHECKED BY:	BAM
SCALE:	AS NOTED
JOB NO.:	20-243
DATE:	06/01/2021
TAX MAP#:	98.18-1-20.10

P100